
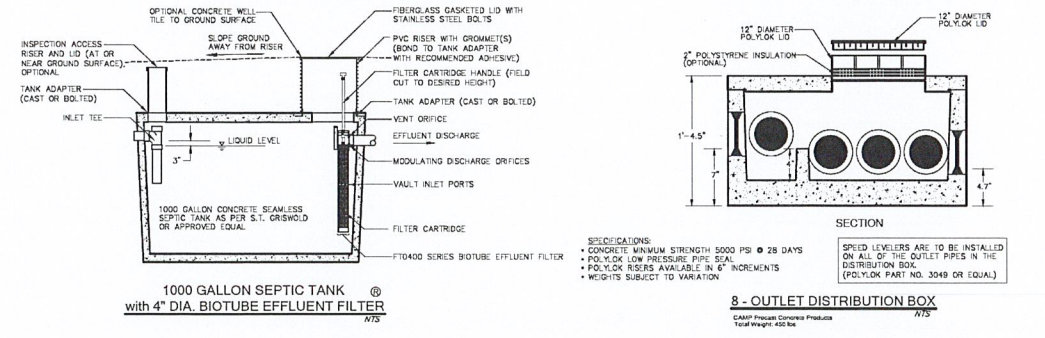
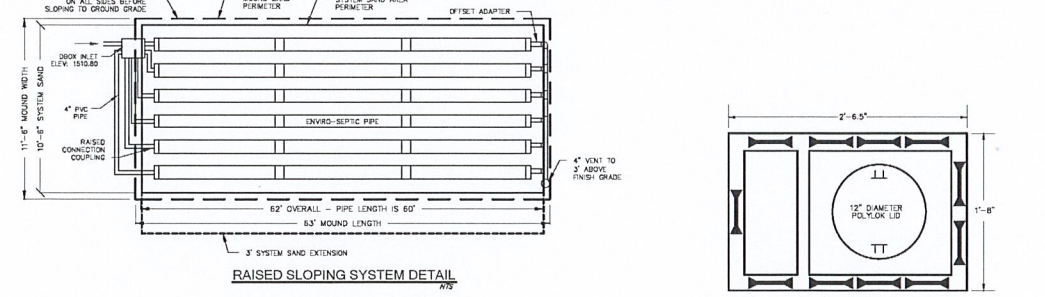
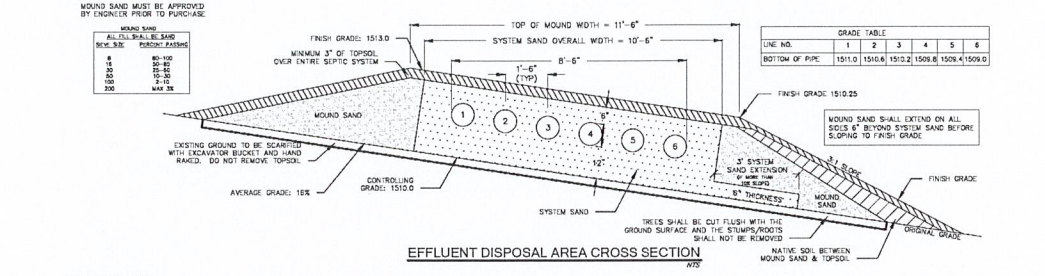
 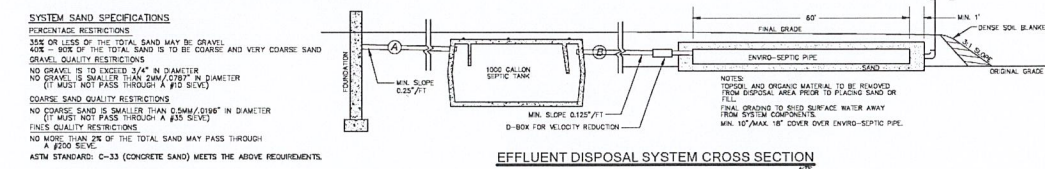


| ITEM                | WELL     | SEPTIC TANK | LEACHFIELD  | MOUND SYSTEM  |
|---------------------|----------|-------------|---|---|
| DROWKEY             | 15'      | 5'          | 10'   | 25' IF ITEM IS DOWNHILL                               |
| HOUSE FOOTING DRAIN | 10'      | 10'         | 35' IF ITEM IS UPHILL OR<br>75' IF ITEM IS DOWNHILL | 35' IF ITEM IS UPHILL OR<br>75' IF ITEM IS DOWNHILL   |
| PROPERTY LINE       | 10'      | 10'         | 25'   | 25' IF ITEM IS DOWNHILL<br>10' ON ALL OTHERS          |
| LEACHFIELD          | 100/200' | —           | 10'   | 10' SIZES, 25' UPHILL/DOWNHILL<br>(REPLACEMENT MOUND) |
| SEPTIC TANK         | 50'      | —           | —   | —   |
| SERVICE WATER LINE  | —        | 25'         | —   | —   |



NOTE: ORIGINAL PLAN 24 " x 36 ". OTHER SIZES NOT TO SCALE

[illegible]

A circular professional engineer seal for the State of Vermont. The outer ring contains the text "STATE OF VERMONT" at the top and "PROFESSIONAL ENGINEER" at the bottom, separated by two stars. The center of the seal contains the text "JOHN D. GRENIER" and "NO. 9018". Below the seal is a handwritten signature in black ink.



## LOT #2 SEPTIC SITE PLAN & DETAILS

DAVID & NORA GRENIER  
BEAR CREEK LANE WATERBURY

|   |   |   |
|---|---|---|
| <h1 style="margin: 0;">GRENIER</h1> <p style="margin: 0;">ENGINEERING, PC<br/>155 DEMERITT PLACE #2</p> | <p style="margin: 0;">P.O. Box 445<br/>Waterbury, VT 05676<br/>TEL (802) 244-6413<br/>FAX (802) 244-1672<br/>grenierengineering.com</p> | <p style="margin: 0;">Date: _____<br/>Dwn By: _____<br/>Scale: _____<br/>Sheet _____<br/>Dwg No _____<br/>File No _____</p> |
|---|---|---|

12 . 12 . 18  
y: JAD/TJM  
1" = 30'  
No: 3 of 3  
Name: GRENIER SP  
p: